


Design Approach Level 01 Floor Plan

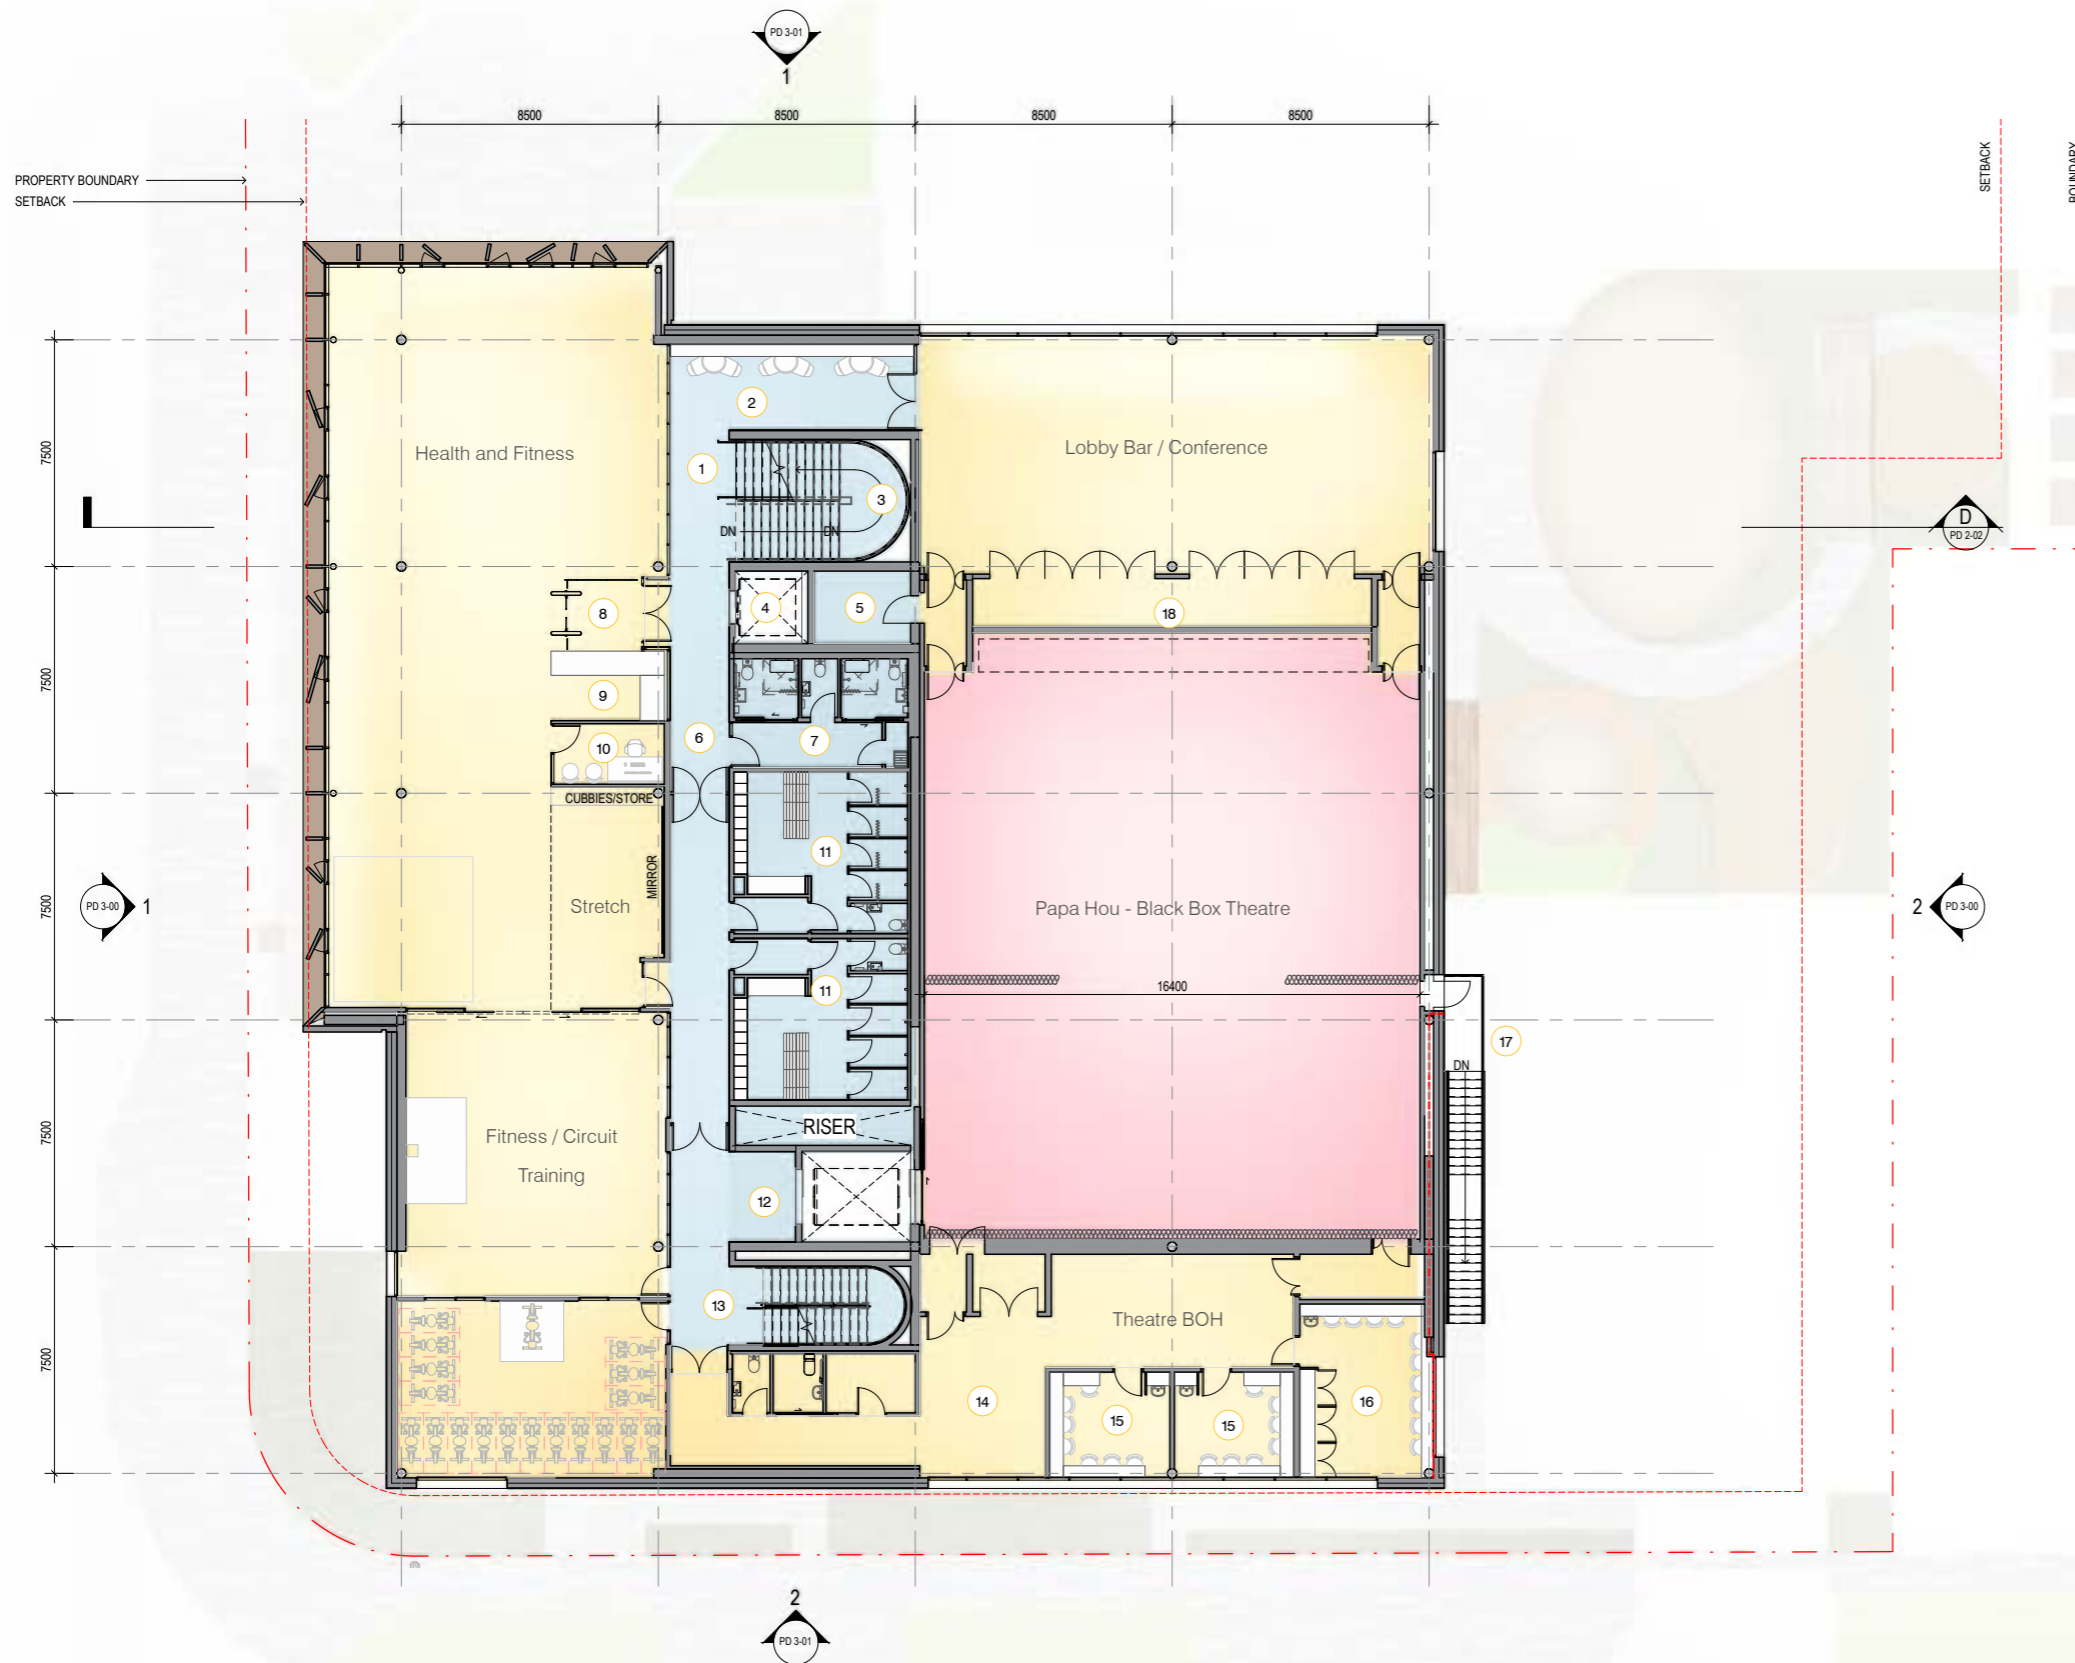


Legend

- Function
- Core / Circulation

Key

- 1 Arrival Point
- 2 Social Space
- 3 Central Stair
- 4 Public Lift
- 5 IT / Services
- 6 Circulation Spine
- 7 Rest-rooms
- 8 Fitness Entry
- 9 Reception
- 10 Consult
- 11 Change
- 12 Services Lift
- 13 Secondary Stair
- 14 Assembly / Props Load In
- 15 Dressing Room
- 16 Green Room / Dressing Room
- 17 Theatre Fire Egress Stair
- 18 Storage

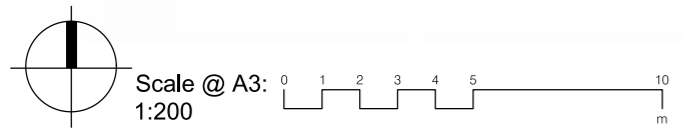

YMCA
architectus™

Drawing: Level 01
 Drawing no: PD 1-01
 Issue: 90% Preliminary Design
 Date: February 16, 2021
 Job no: 1836