



Design Approach Level 02 Floor Plan

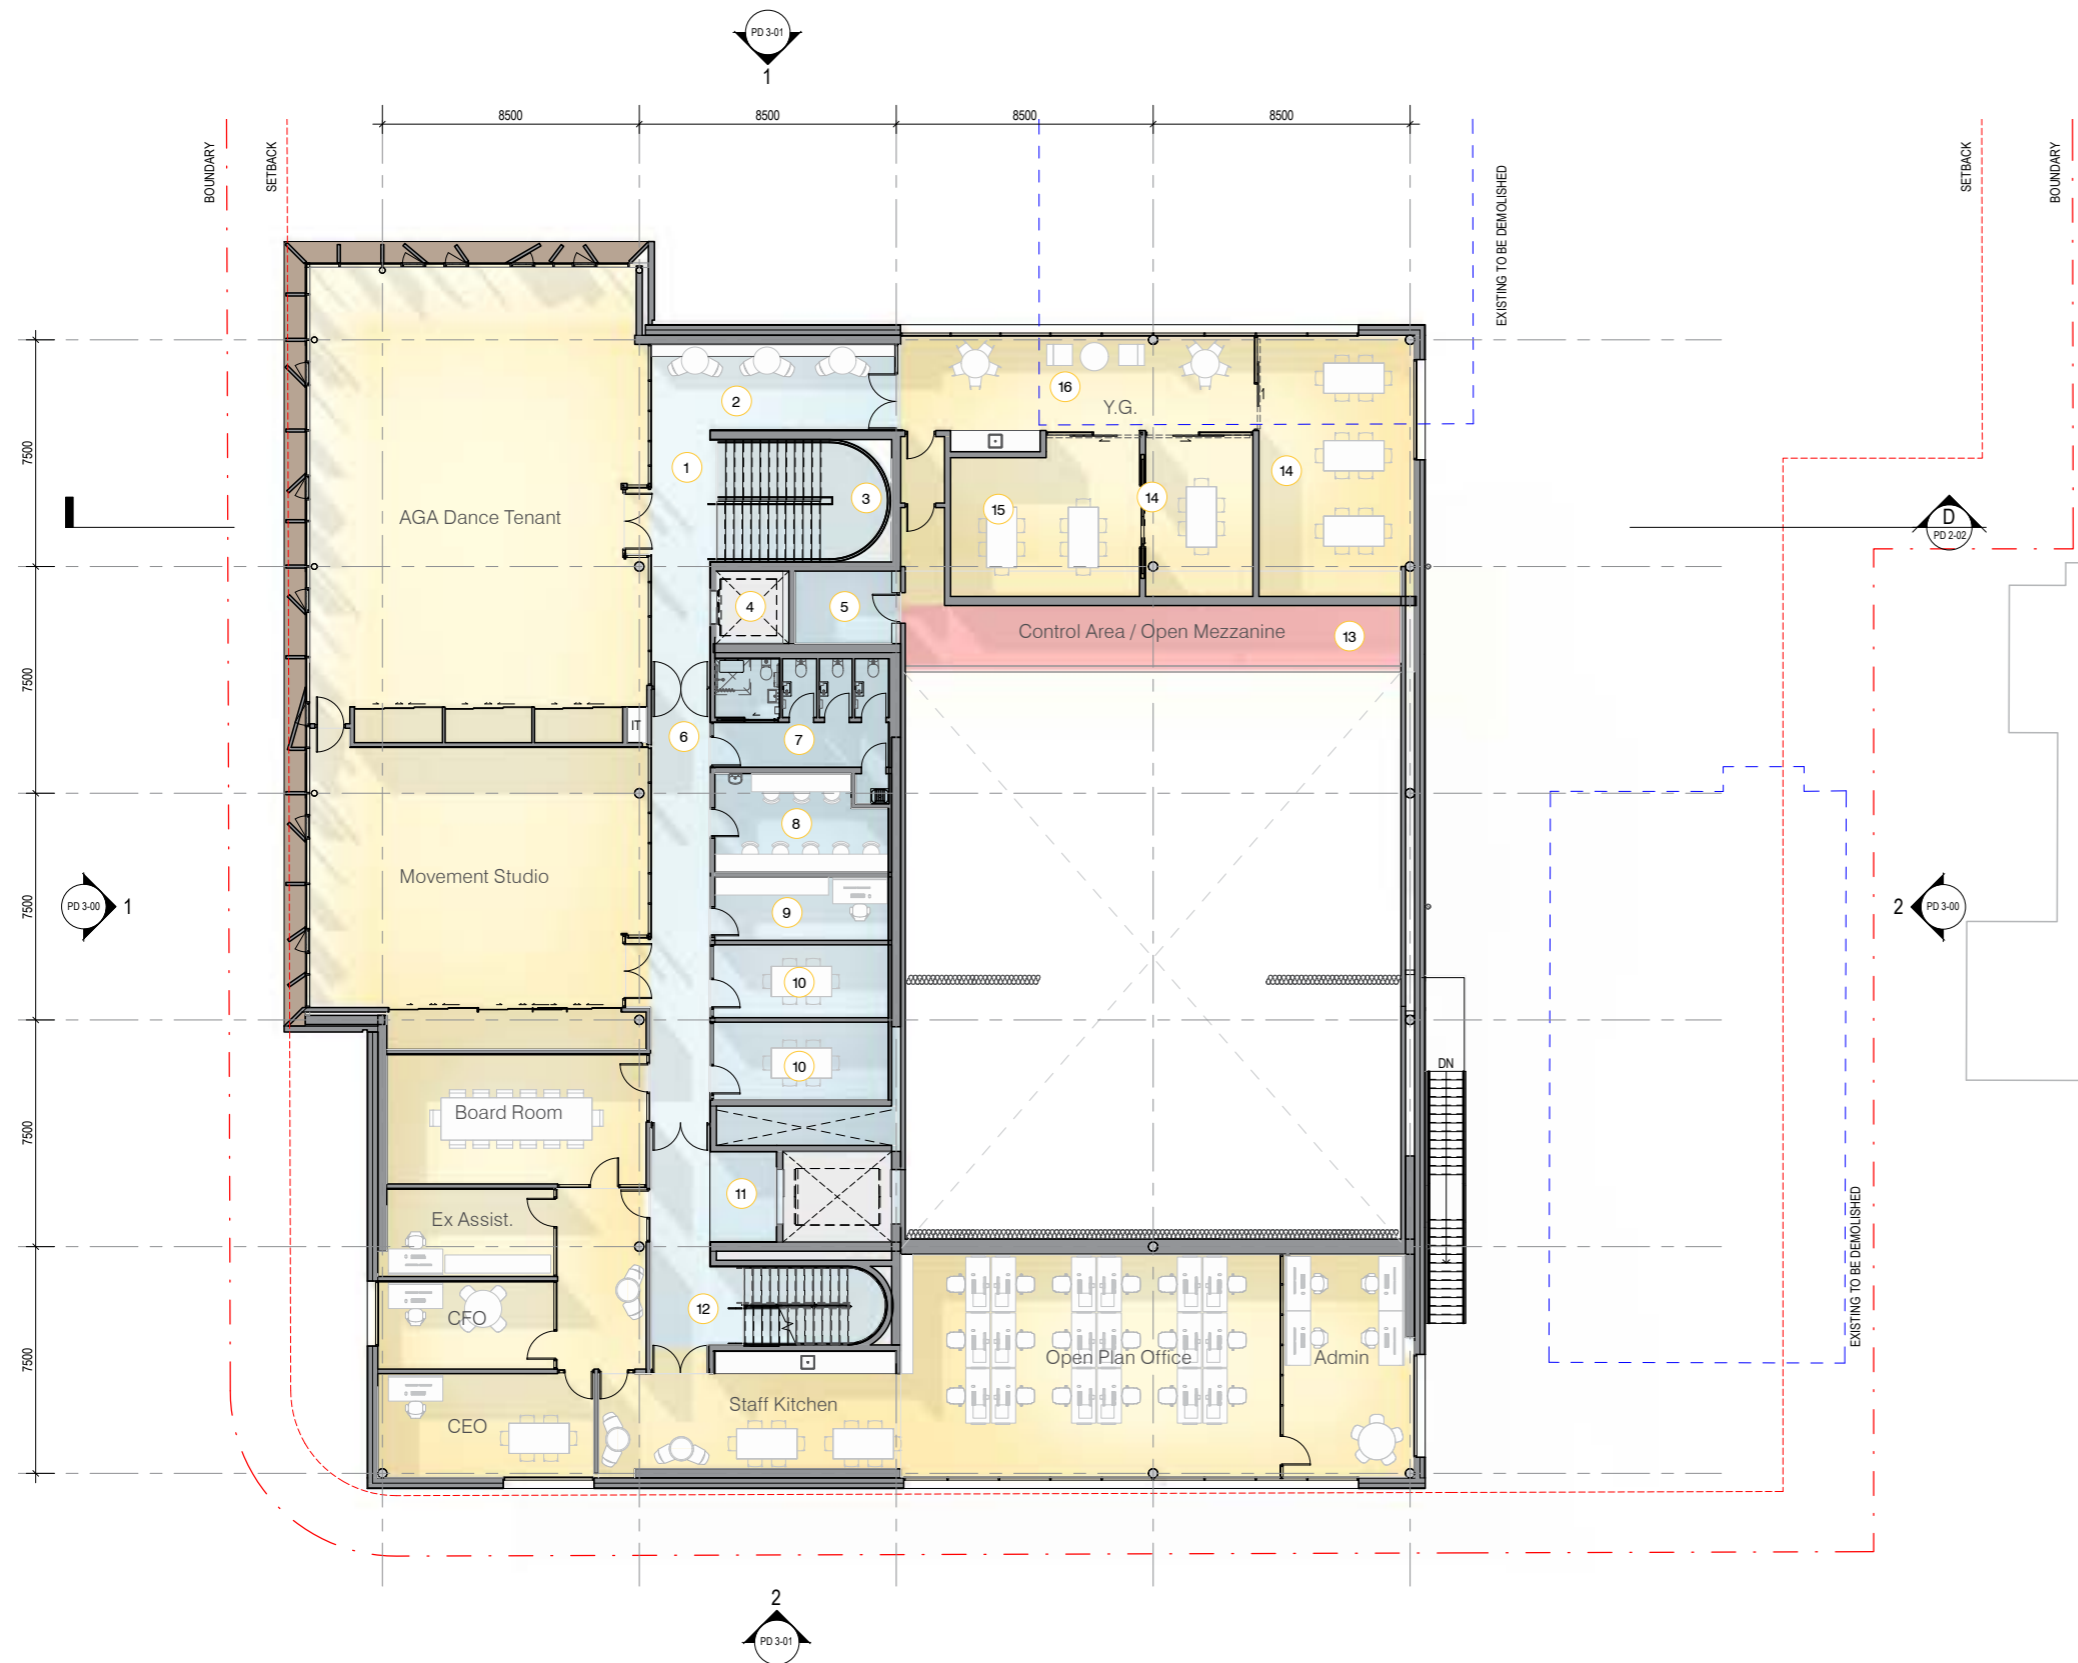

- Legend
- Function
 - Core / Circulation
- Key
- ① Arrival Point
 - ② Social Space
 - ③ Central Stair
 - ④ Public Lift
 - ⑤ IT / Services
 - ⑥ Circulation Spine
 - ⑦ Rest-rooms
 - ⑧ AGA Change
 - ⑨ AGA Office
 - ⑩ Meeting Rm.
 - ⑪ Services Lift
 - ⑫ Secondary Stair
 - ⑬ Access to Theatre Technical Level
 - ⑭ Classroom
 - ⑮ Office
 - ⑯ YG Breakout with Kitchenette

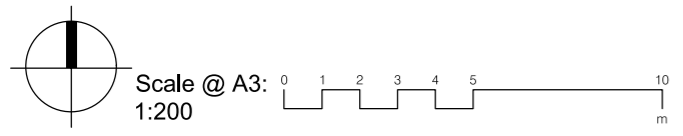

YMCA
architectus™

Drawing: Level 02
 Drawing no: PD 1-02
 Issue: 90% Preliminary Design
 Date: February 16, 2021
 Job no: 1836